




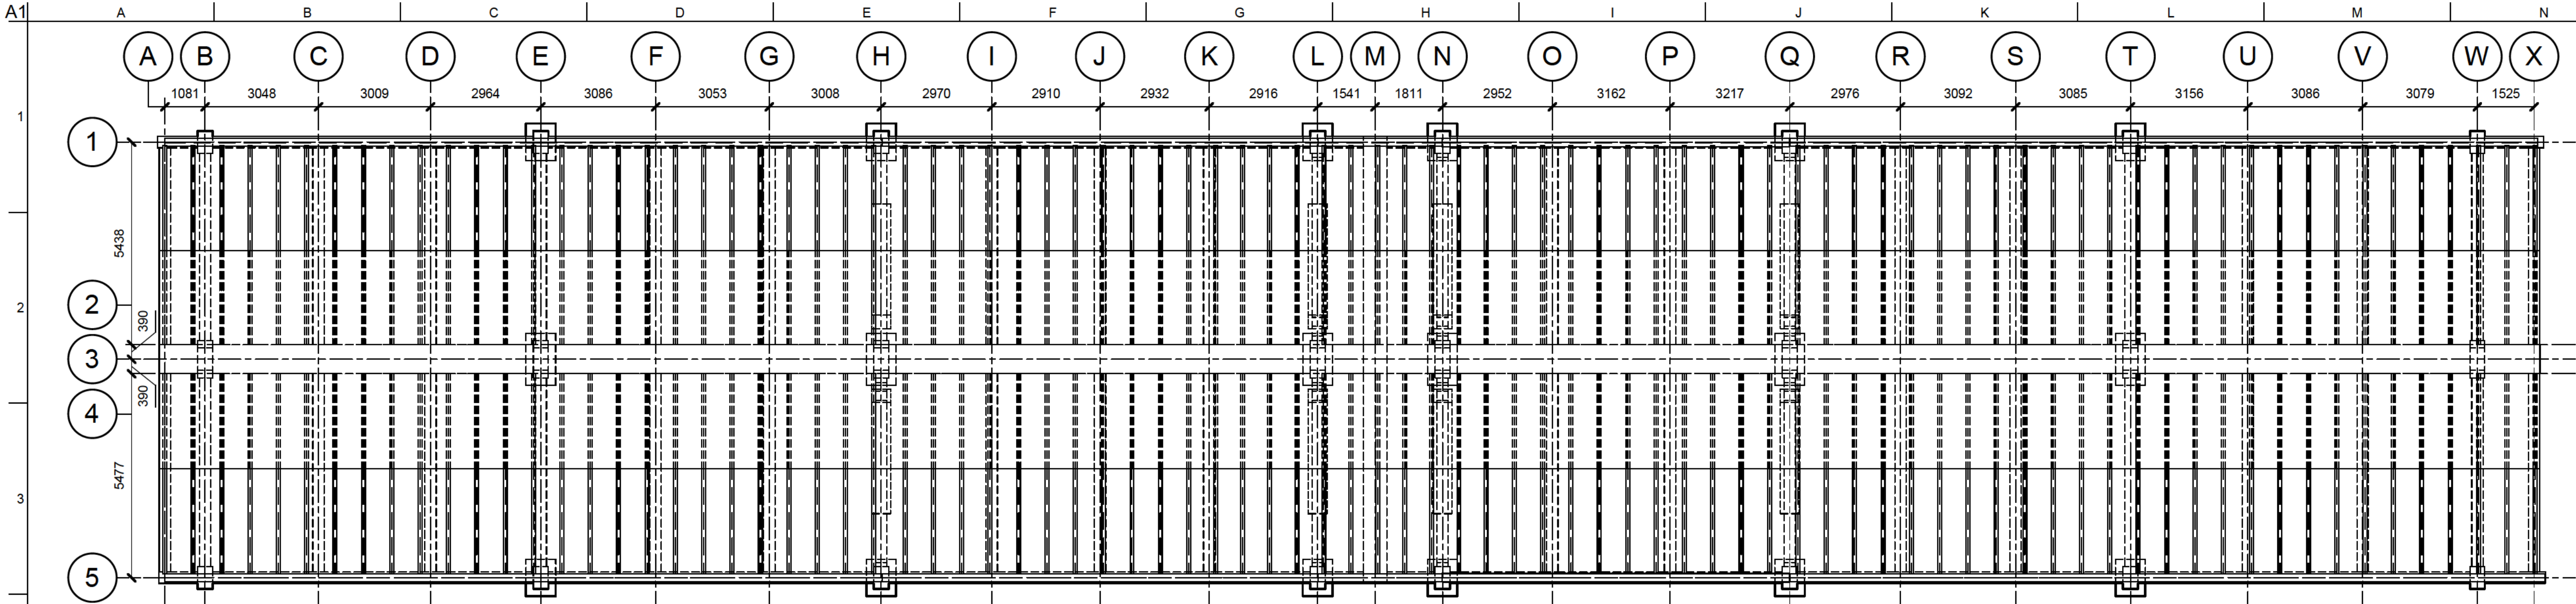

Upper Deck
Scale 1 : 100

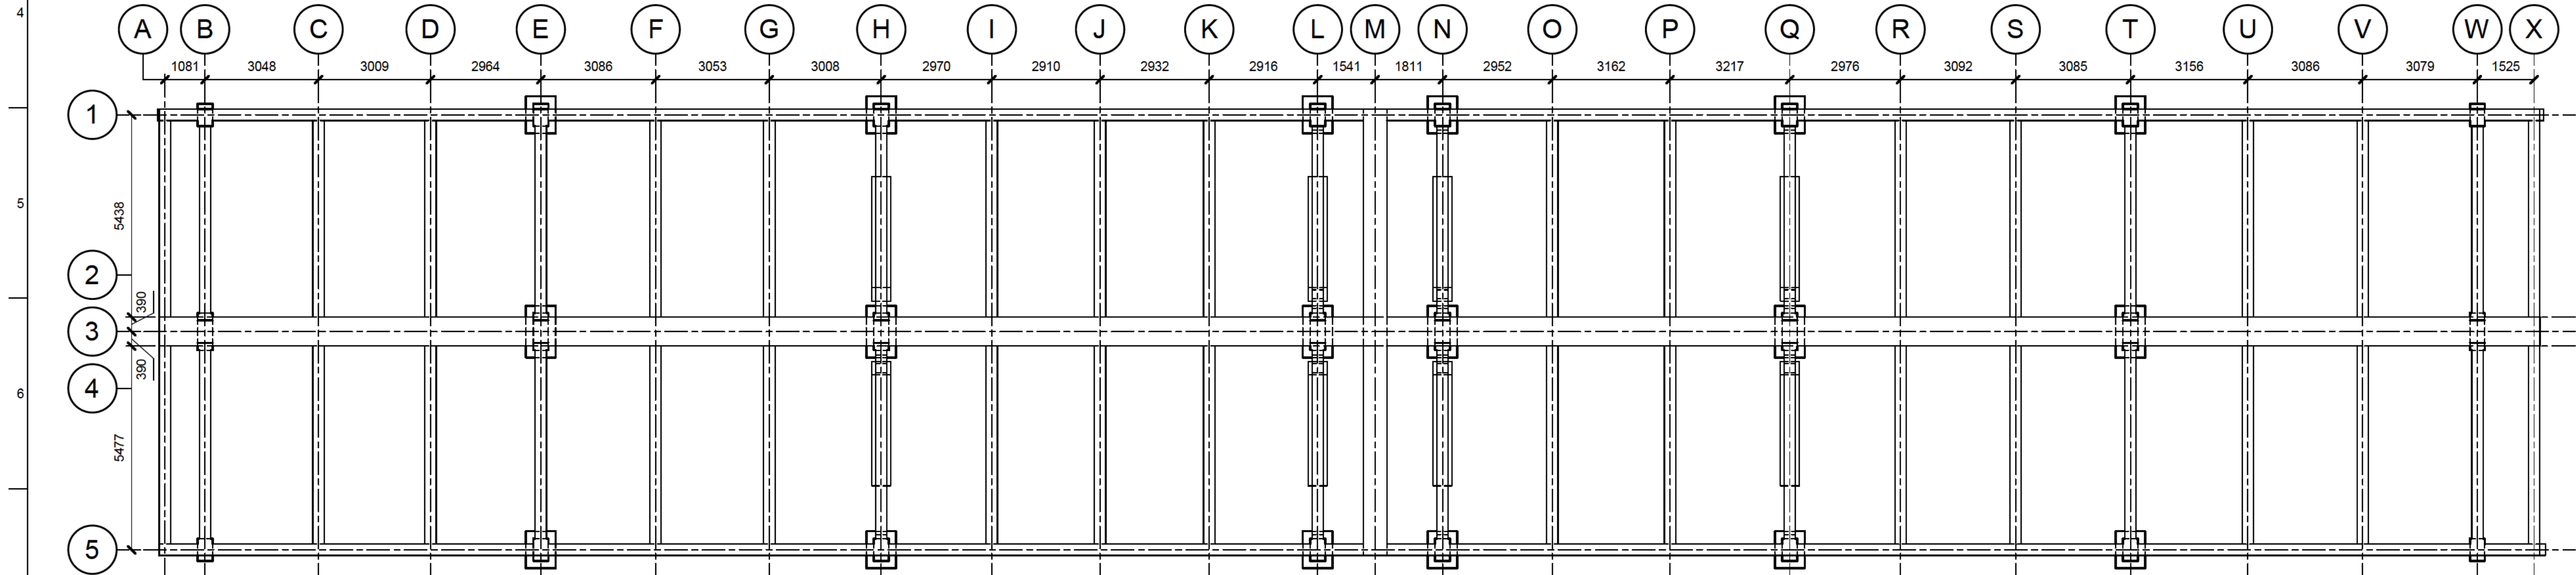

Framing plan
Scale 1 : 100

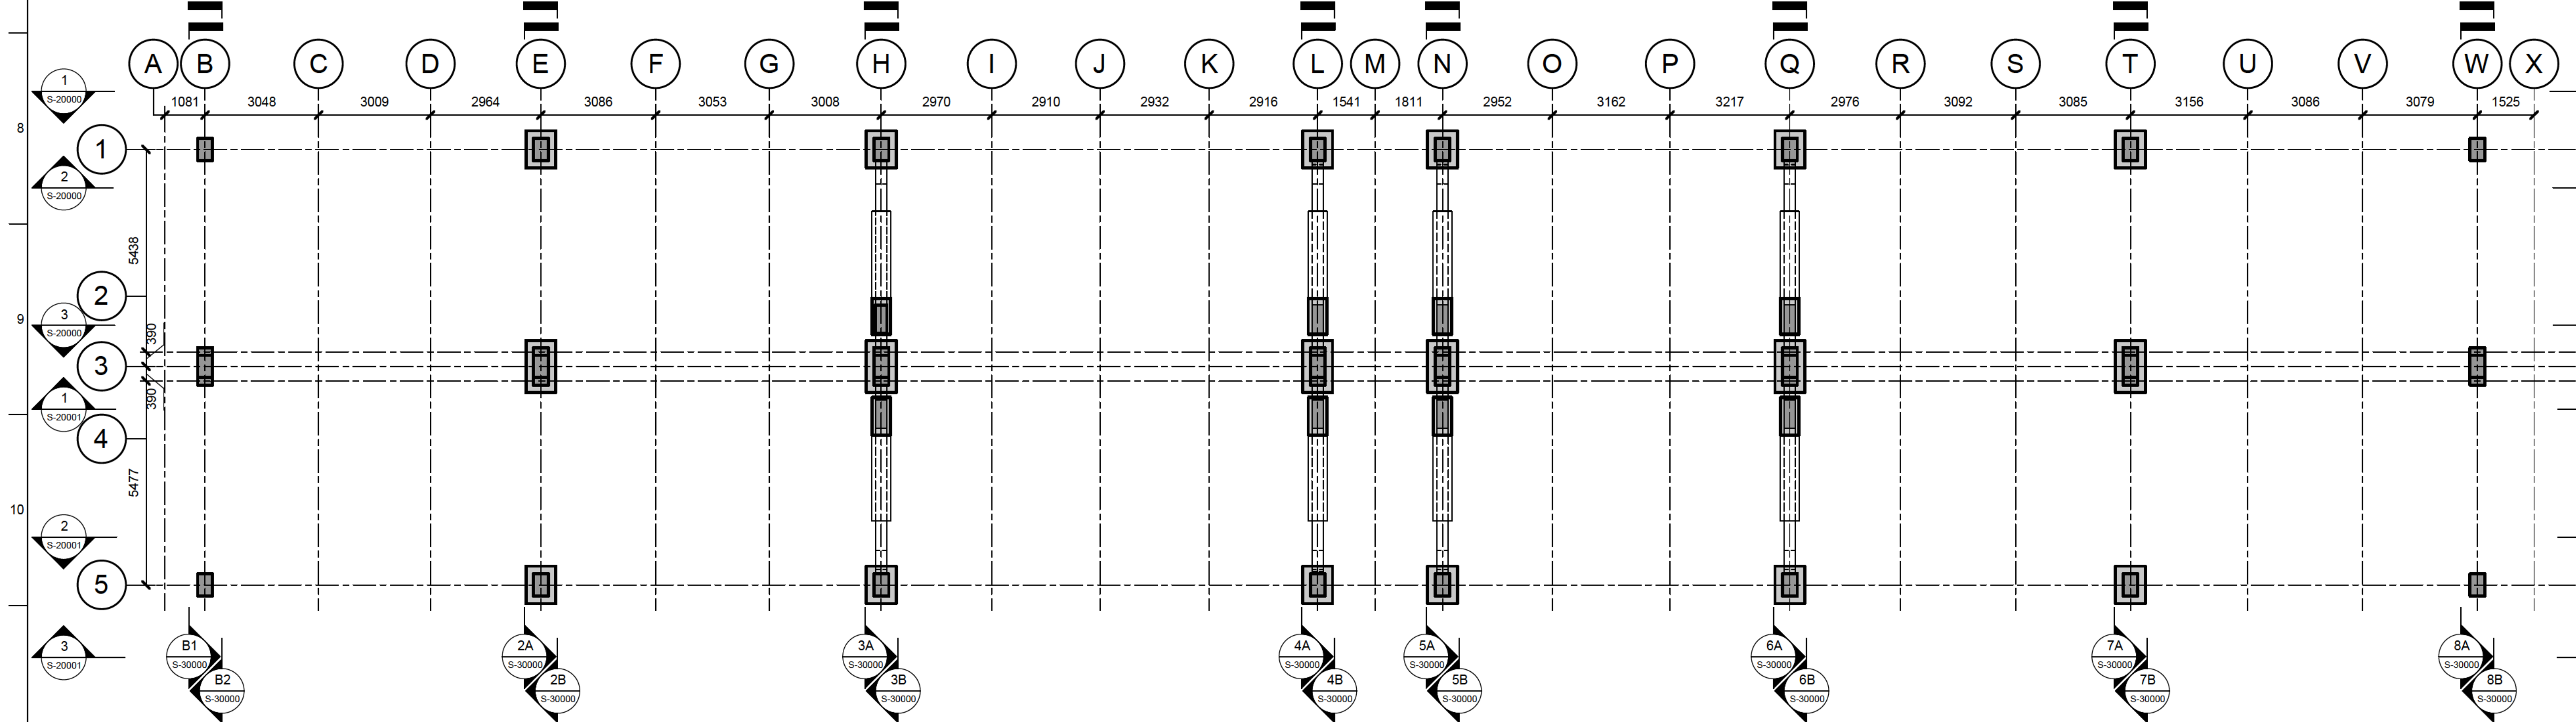

Water Level
Scale 1 : 100

P01 | 01/06/26 | For Information

Issue	Date	Description
-------	------	-------------

ARUP

8 Fitzroy Street
London W1T 4BJ
Tel +44 (0)20 7636 1531 Fax +44 (0)20 7580 3924
www.arup.com

Client
Short Brothers PLC

Project Title
Connswater Bridge

Drawing Title
General Arangment

Scale at A1	1 : 100	Dsg/Drw/Chkd/Appd
Role	Structural	
Status	S1 - Suitable for Stage Approval	
Arup Job No	24189	Rev P01
ID	24189-ARP-ZZ-ST-S-10000	